




ROOF PLAN - ARCADE BUILDING
scale 1:100

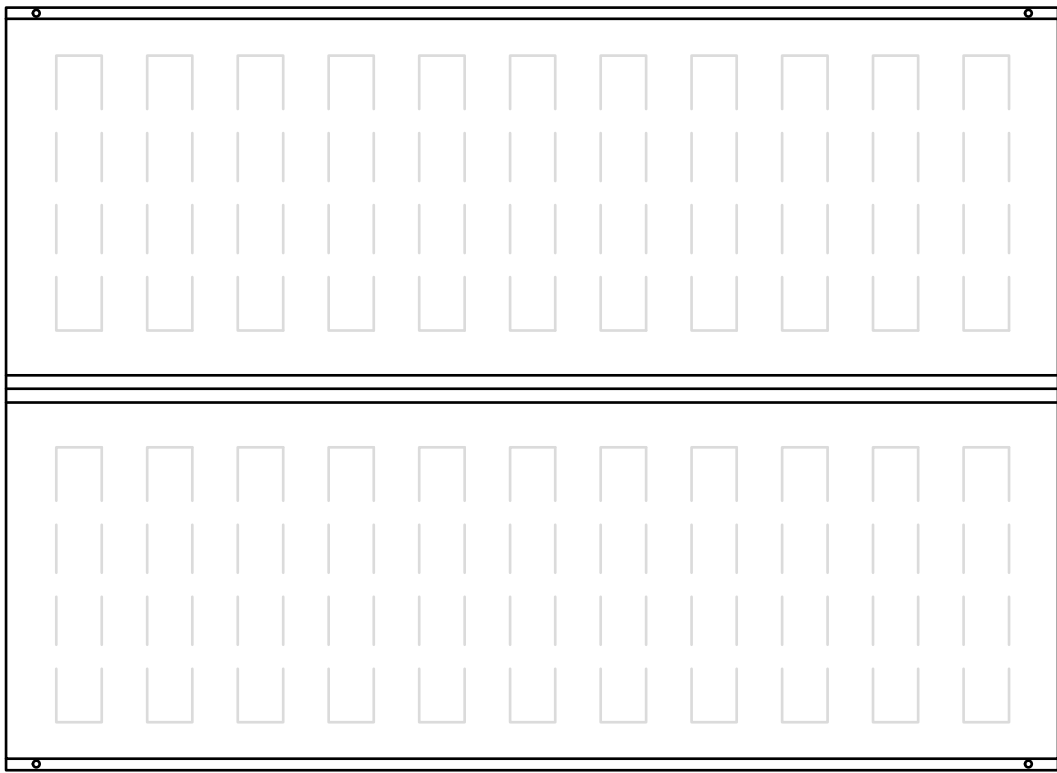


ROOF PLAN - WORKSHOP BUILDING
scale 1:100

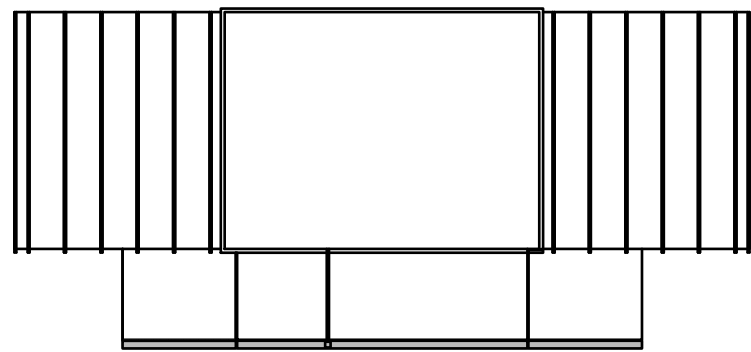


ROOF PLAN - STATION BUILDING
scale 1:100

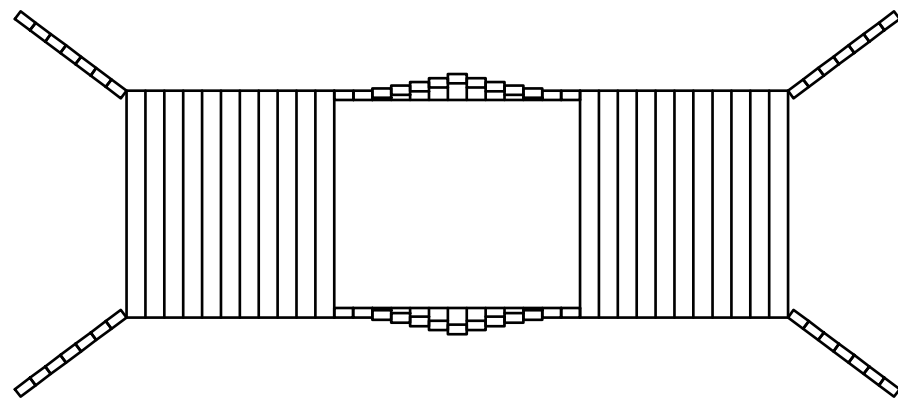

ROOF PLAN - TUNNEL STRUCTURE
scale 1:100

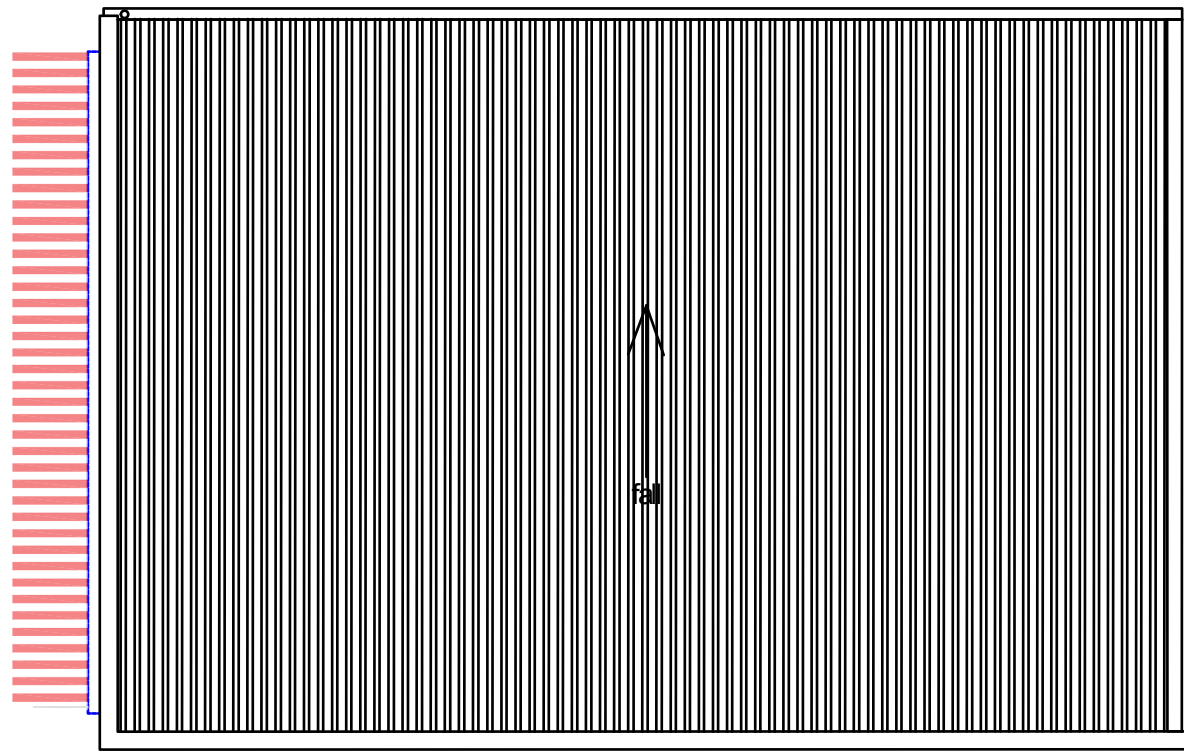

ROOF PLAN - HALL OF MIRRORS BUILDING
scale 1:100

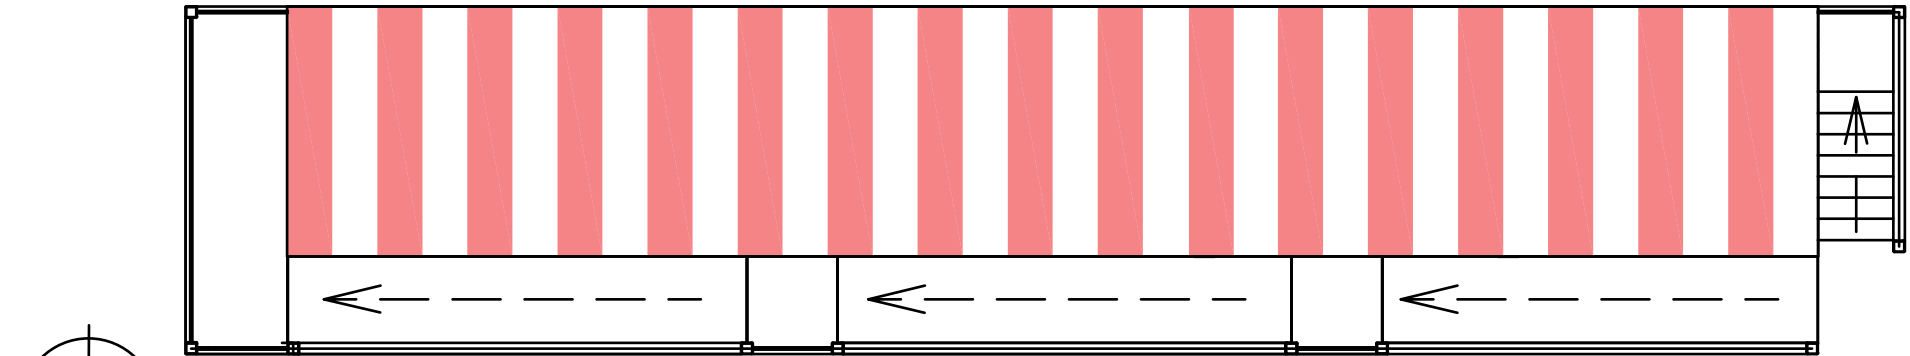

ROOF PLAN - GRANDSTAND BUILDING
scale 1:100



ELEVATION OF STREET LAMP WITH GLOBE
scale 1:50

<http://www.outdoorlightingireland.com/castironlighting/globe.aspx>

- ☐ AS BUILT DRAWING
- ☐ LICENSING
- ☐ SURVEY
- ☐ CONSTRUCTION ISSUE
- ☒ TENDER ISSUE
- ☐ BUILDING REGULATIONS
- ☒ LPA SUBMISSION
- ☐ LPA PRE-APP DRAWING
- ☐ FEASIBILITY DRAWING
- ☐ CLIENT APPROVAL
- ☐ REVISION

Rev	Date	Description
01	8/18	TENDER # LPA

Customer BRAND:



Project:
NEW FAIRGROUND AND
ARCADE DEVELOPMENT

Client:
BUTLINS RESORT
ROMAN BANK
SKEGNESS
PE25 1NJ



Drawn: JD Approved: AUG 2018
Scale: 1:100/50 @ A1 PRINT SIZE

Sheet Description:
ROOF LAYOUT PLANS & STREET
LIGHT ELEVATION

Sheet Number:
IPL_18_131.62_127
Issue:
01-TND

